


# Lighting Plan

# Statistics


Description	Symbol	Avg	Max	Min	Max/Min	Avg/Min
Building Perimeter	+	0.9 fc	32.0 fc	0.0 fc	N/A	N/A
Drive	✖	1.3 fc	32.0 fc	0.0 fc	N/A	N/A
Norhtwest Canopy	+	9.4 fc	26.7 fc	0.0 fc	N/A	N/A
North West Canopy	✖	18.3 fc	32.0 fc	13.7 fc	2.3:1	1.3:1
Property Line	✖	0.0 fc	0.9 fc	0.0 fc	N/A	N/A
Southwest Canopy	+	18.9 fc	42.3 fc	9.8 fc	4.3:1	1.9:1

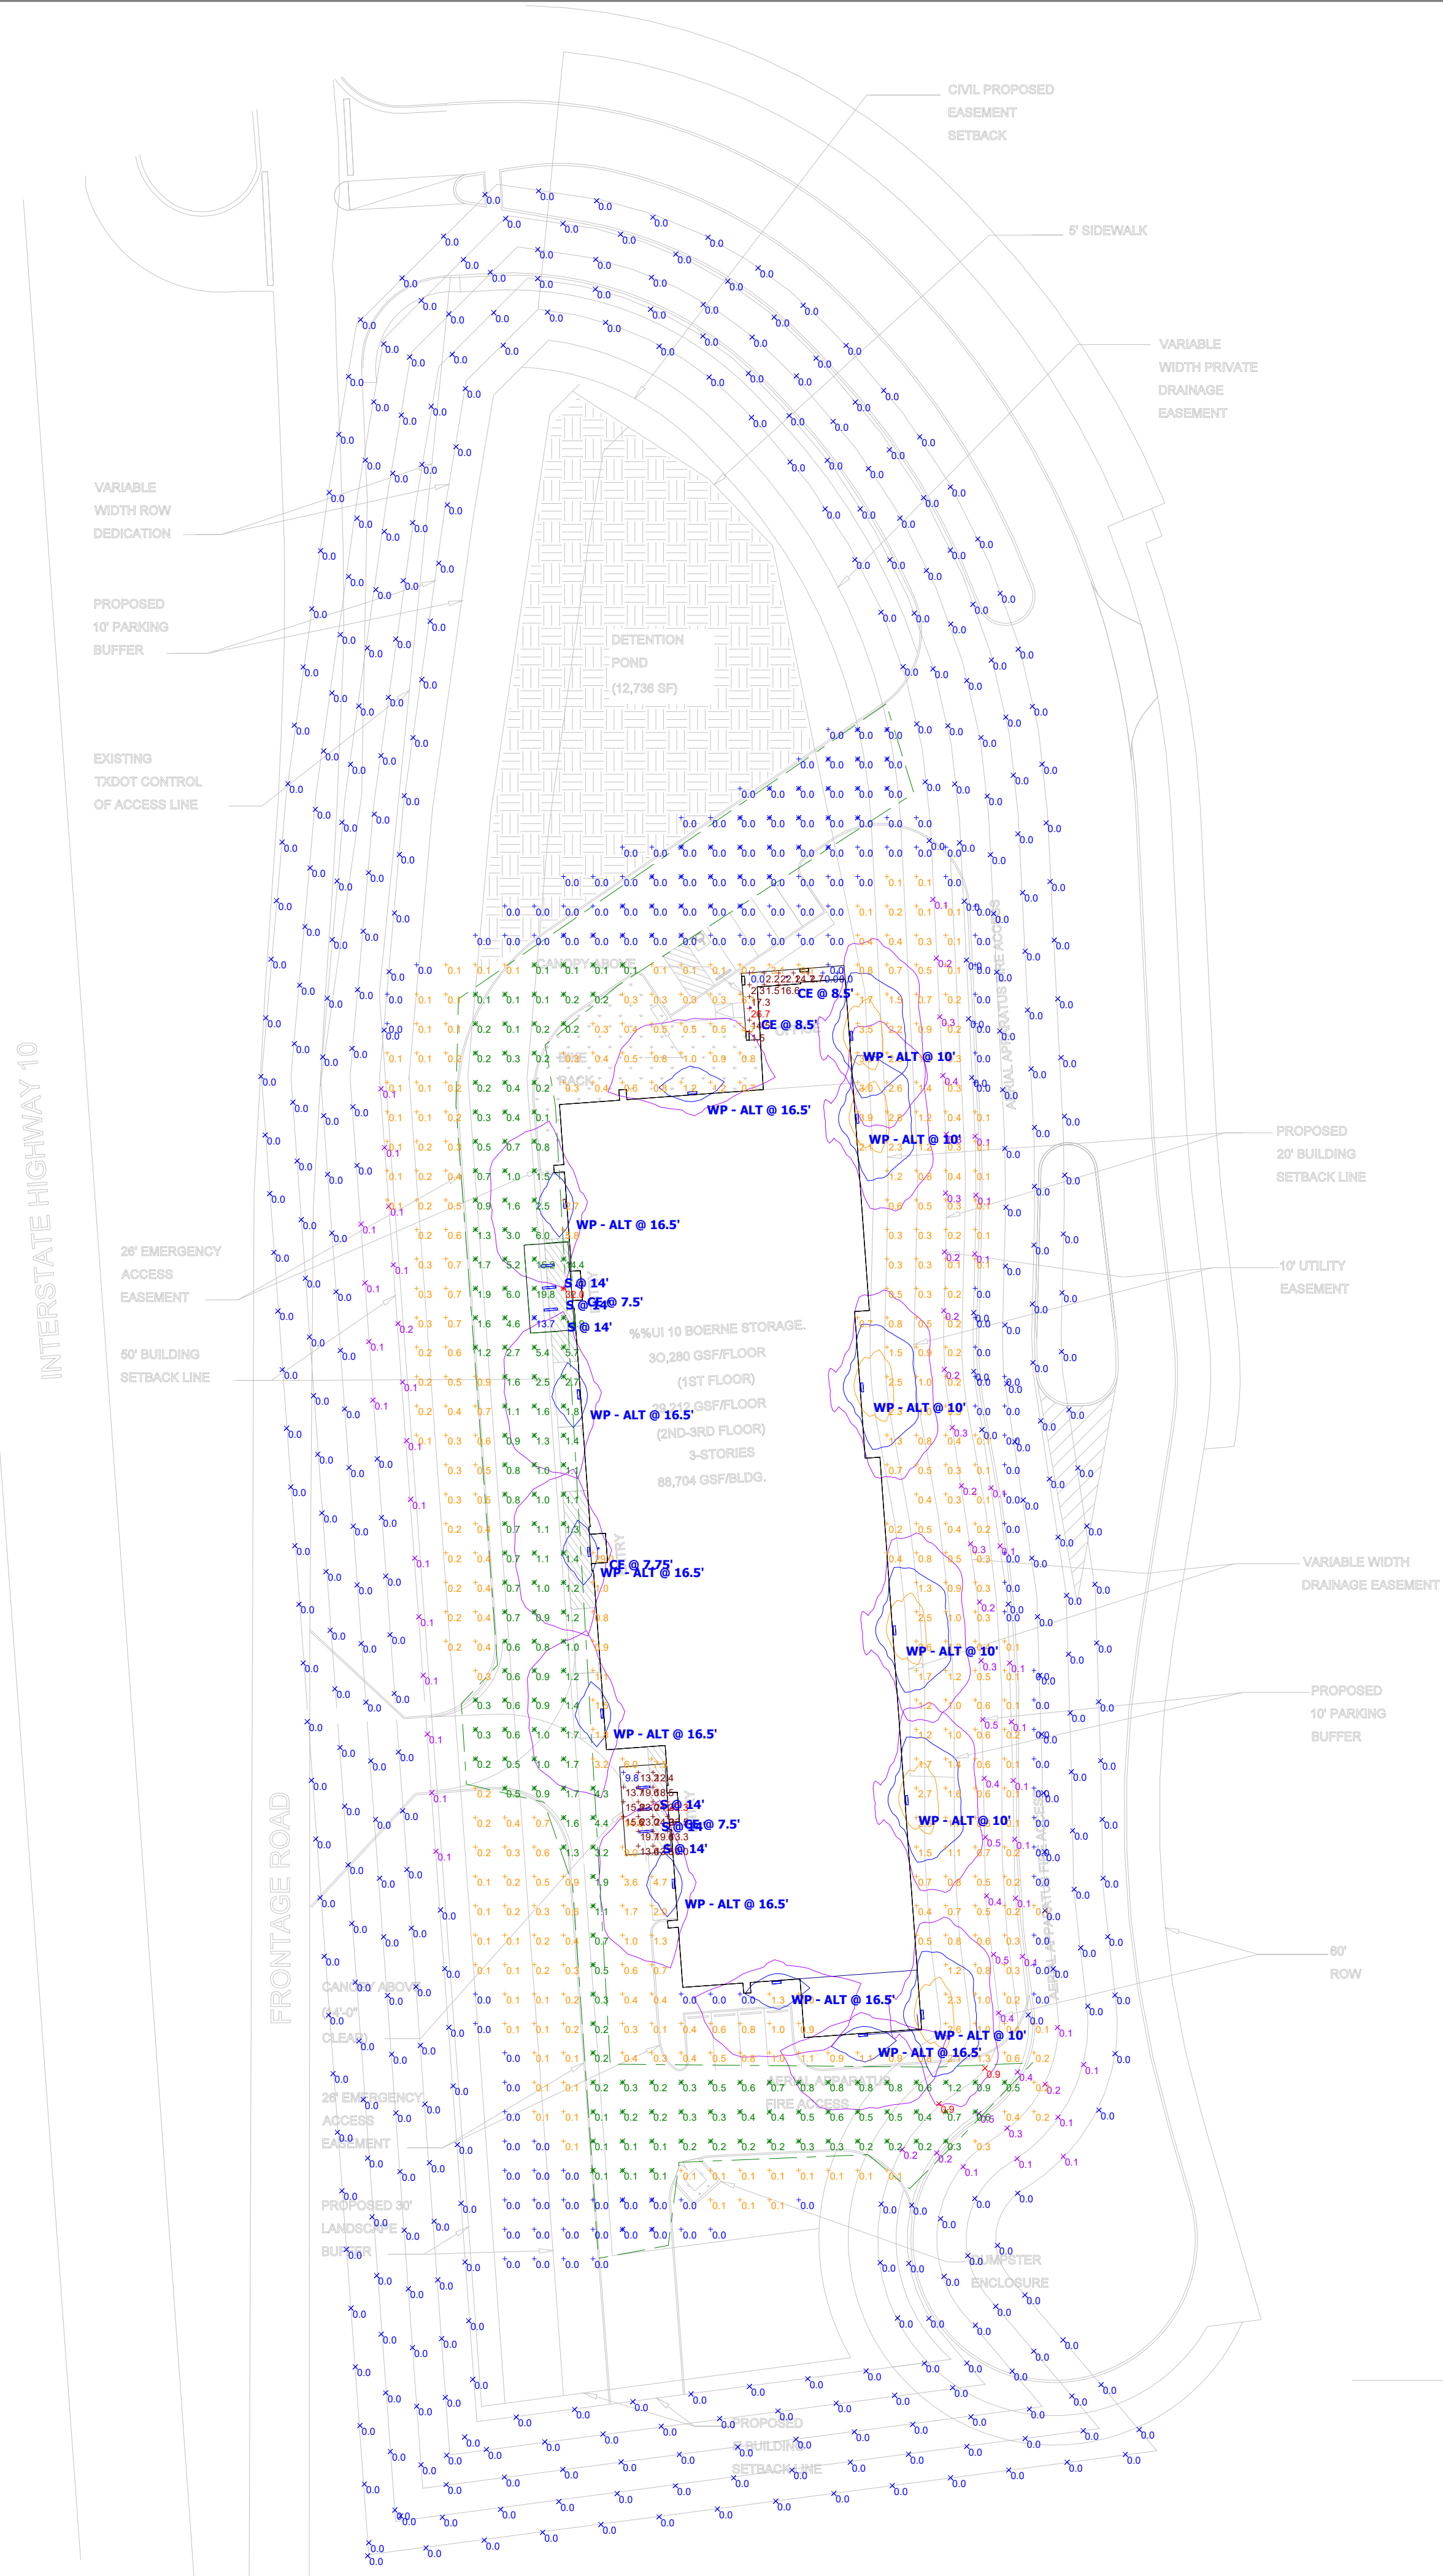

Plan View  
Scale - 1" = 40ft

## SCHEDULE - NOT FOR USE IN CONSTRUCTION DOCUMENTS

Symbol	Label	Quantity	Manufacturer	Catalog Number	Description	Lamp	Number Lamps	Filename	Lumens Per Lamp	Light Loss Factor	Wattage	Distribution
WP - ALT	WP - ALT	14	Lithonia Lighting	DSXW1 LED 20C 350 40K T3M MVOLT	DSXW1 LED WITH (2) 10 LED LIGHT ENGINES, TYPE T3M OPTIC, 4000K, @ 350mA.		1	DSXW1_LED_20C_350_40K_T3M_MVOLT.ies	2965	0.95	23.3	TYPE IV, MEDIUM, BUG RATING: B1 - U0 - G1
CE	CE	5	Lithonia Lighting	LDN6 40/25 L06AR LD	6IN LDN, 4000K, 2500LM, CLEAR, MATTE DIFFUSE REFLECTOR, CRI80		1	LDN6_40_25_L06AR_LD.ies	2244	0.95	28.25	DIRECT, SC-0=1.02, SC-90=1.03
S	S	6	Lithonia Lighting	VAP 8000LM FST WD 40K 80CRI	VAP LED with BLT Gen 2 Boards		1	VAP_8000LM_FST_WD_40K_80CRI.ies	7406	0.95	66.86	DIRECT, SC-0=1.22, SC-90=1.32

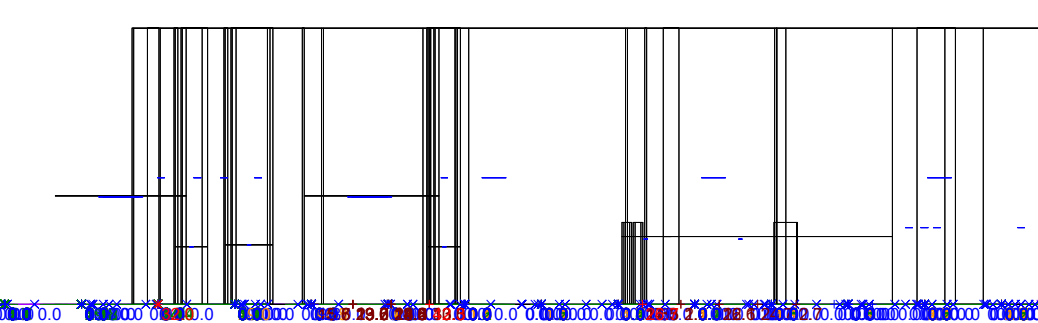

South View  
Scale - 1" = 25ft

**Note**  
 1. ALL EXTERIOR CALCULATIONS ARE ASSUMED ON EVEN OR FLAT TERRAIN.  
 2. ALL EXTERIOR CALCULATIONS ARE TAKEN AT 0'-0" AFG.  
 3. VALUE NEXT TO LUMINAIRE LABEL DRAWING REPRESENTS OVERALL MOUNTING HEIGHT.

This document was prepared to convey a concept and not a detail working system. Spectrum Lighting San Antonio LLC makes no representation, express or implied, with respect to the use of the information conveyed in this document, regardless of its format or the means of its distribution. Any specific information regarding the installation must be provided by the manufacturer of the equipment. There is no guarantee or representation to the user as to the accuracy, currency, suitability, or reliability of this document for any purpose.  
 The fixture schedule above does not contain the complete fixture nomenclature required for construction or bidding purposes. The fixture nomenclature listed in the photometric file of the base fixture.  
 Please contact Spectrum Lighting San Antonio for a complete fixture schedule.

I-10 BOERNE / CIBOLO VISTA STORAGE

Designer  
DREW BENSON  
Date  
08/01/2024  
Scale  
Not to Scale  
Drawing No.  
REV 3  
Summary